

NOTES: 说明: SCALE: 绘图比例: 1:50
1. DIMENSIONS: 尺寸: ALL DIMENSIONS ARE TO FACE UNLESS OTHERWISE SPECIFIED.
2. FINISHES: 饰面: SEE FINISH SCHEDULE FOR DETAILS.
3. MATERIALS: 材料: SEE MATERIAL SCHEDULE FOR DETAILS.
4. CONSTRUCTION: 施工: SEE CONSTRUCTION SPECIFICATIONS FOR DETAILS.
5. THE CONTRACTOR SHALL VERIFY ALL DIMENSIONS ON SITE PRIOR TO COMMENCEMENT OF WORK.
6. THE CONTRACTOR SHALL BE RESPONSIBLE FOR OBTAINING ALL NECESSARY PERMITS AND APPROVALS.
7. THE CONTRACTOR SHALL MAINTAIN ACCESS TO ALL ADJACENT PROPERTIES AT ALL TIMES.
8. THE CONTRACTOR SHALL PROTECT ALL EXISTING UTILITIES AND STRUCTURES.
9. THE CONTRACTOR SHALL MAINTAIN A SAFE WORKING ENVIRONMENT AT ALL TIMES.
10. THE CONTRACTOR SHALL BE RESPONSIBLE FOR DISPOSING OF ALL WASTE AND DEBRIS.
11. THE CONTRACTOR SHALL MAINTAIN A CLEAN WORKING ENVIRONMENT AT ALL TIMES.
12. THE CONTRACTOR SHALL BE RESPONSIBLE FOR OBTAINING ALL NECESSARY PERMITS AND APPROVALS.
13. THE CONTRACTOR SHALL MAINTAIN ACCESS TO ALL ADJACENT PROPERTIES AT ALL TIMES.
14. THE CONTRACTOR SHALL PROTECT ALL EXISTING UTILITIES AND STRUCTURES.
15. THE CONTRACTOR SHALL MAINTAIN A SAFE WORKING ENVIRONMENT AT ALL TIMES.
16. THE CONTRACTOR SHALL BE RESPONSIBLE FOR DISPOSING OF ALL WASTE AND DEBRIS.
17. THE CONTRACTOR SHALL MAINTAIN A CLEAN WORKING ENVIRONMENT AT ALL TIMES.


梅沙消防救援站场库室改造项目

图例	说明	备注
△	新建	
△	改建	
△	拆除	
△	保留	
△	其他	

二楼接待餐厅平面布置图

项目名称	梅沙消防救援站场库室改造项目
建设单位	梅沙消防救援站
设计单位	恒业设计
设计人	张子豪
审核人	张子豪
日期	2025-05
比例	1:50
图号	2025-05
备注	

平面布置图

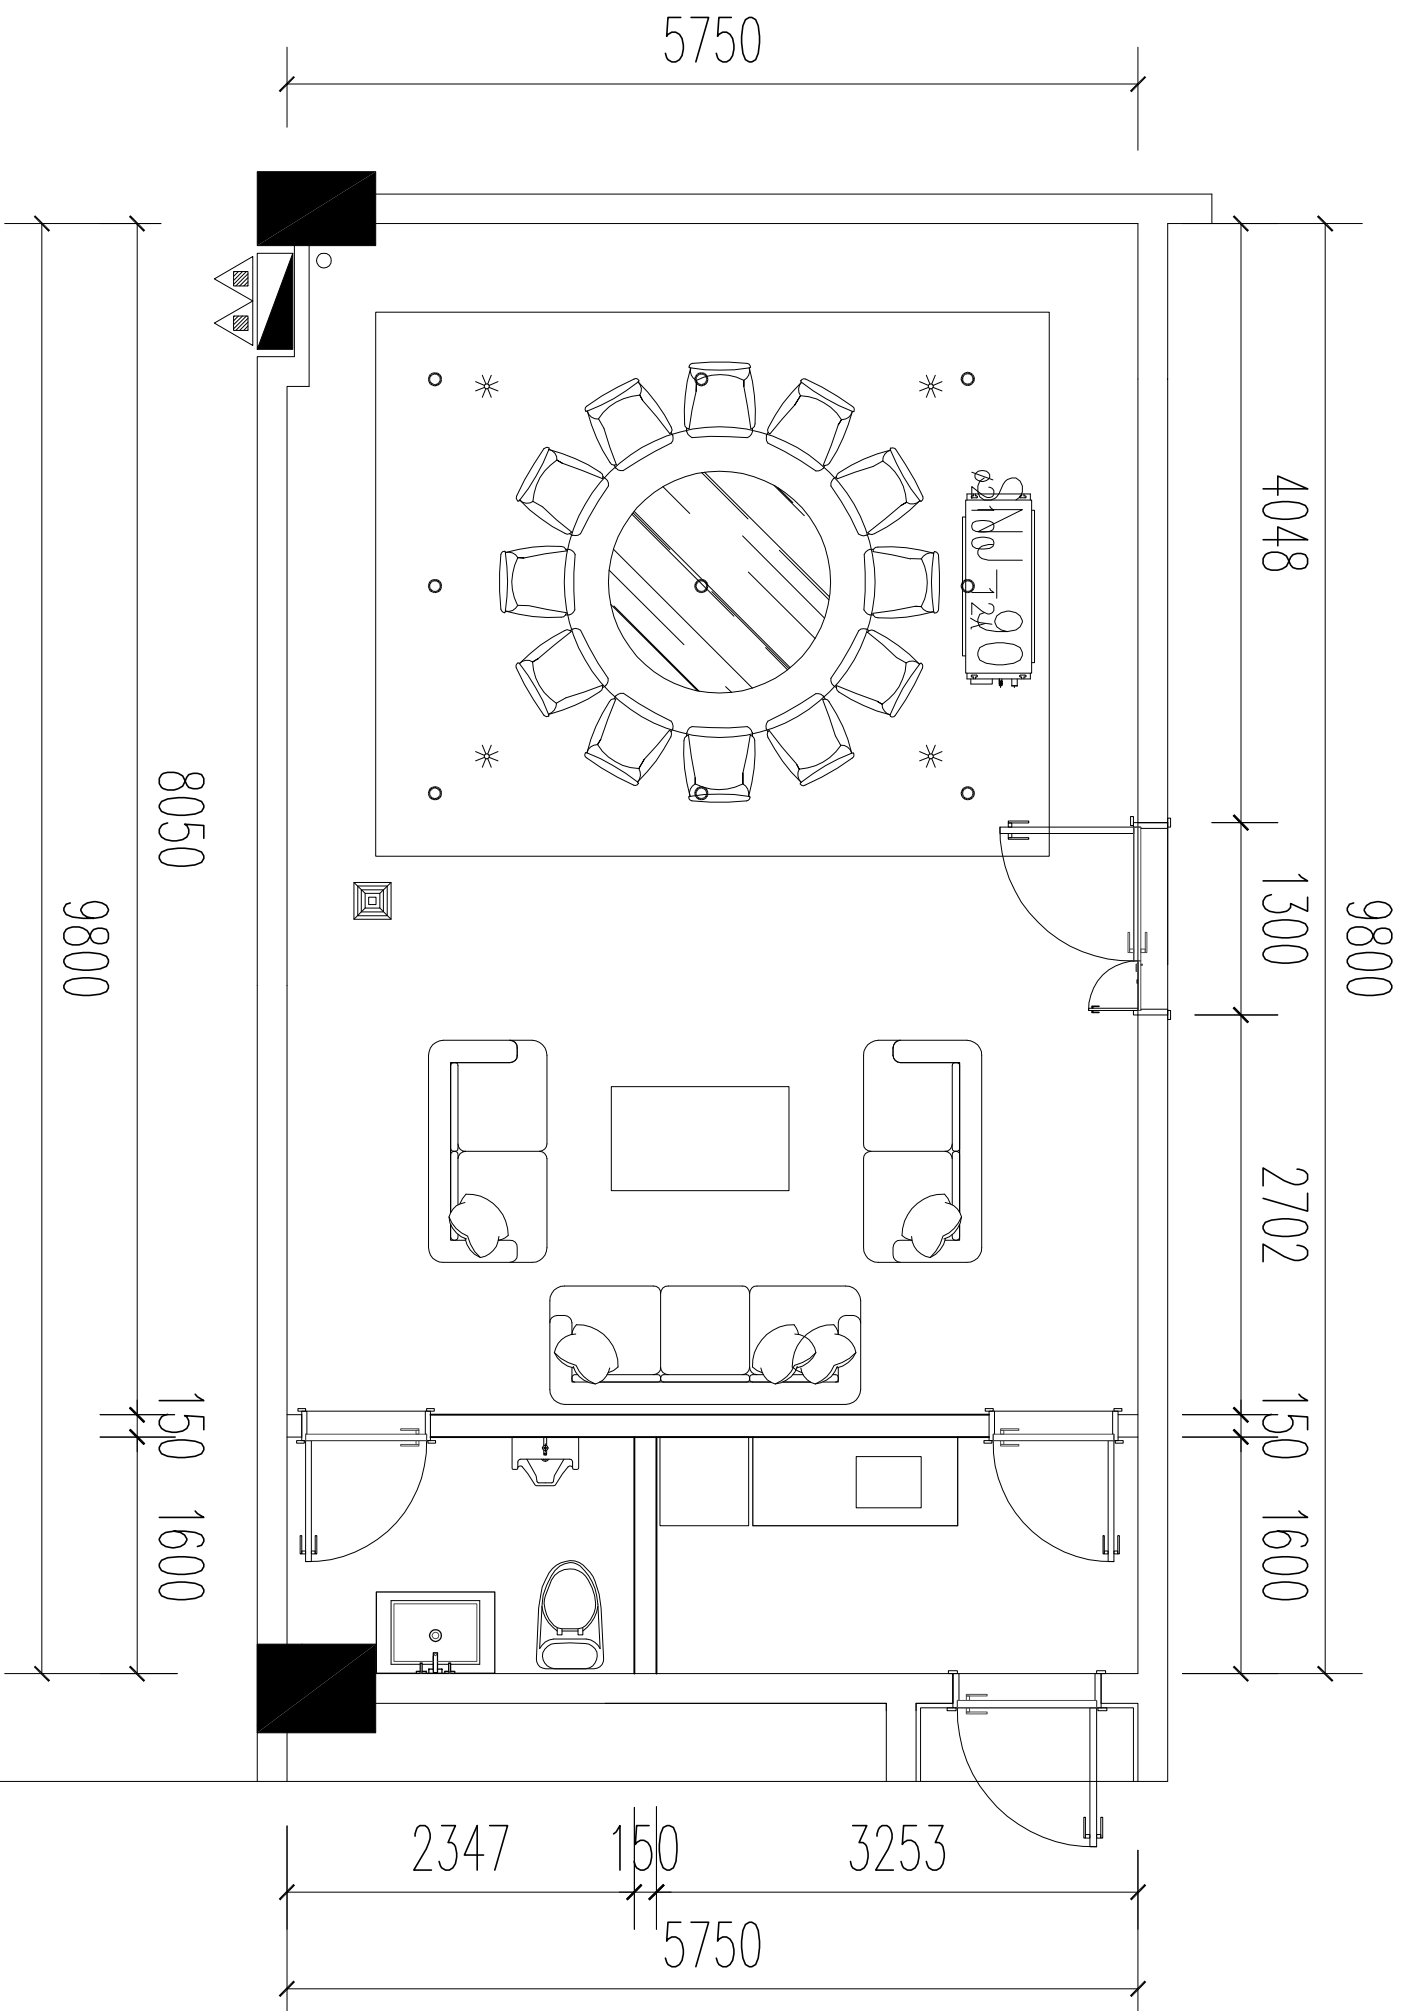

FURNITURE/FIXTURE PLAN
二楼接待餐厅平面布置图
SCALE 1:50@A2